


A10 - Kitchen & Bath Remodel Electrical Plan

THIS DRAWING DEPICTS MINIMUM CODE REQUIREMENTS PER CRC INFORMATION IS FOR REFERENCE ONLY AND IS NOT A SUBSTITUTE FOR ACCURATE DRAWINGS PREPARED FOR EACH PROPOSED CONSTRUCTION PROJECT.


GARAGE WALL & DOOR: SEE SHEET A2

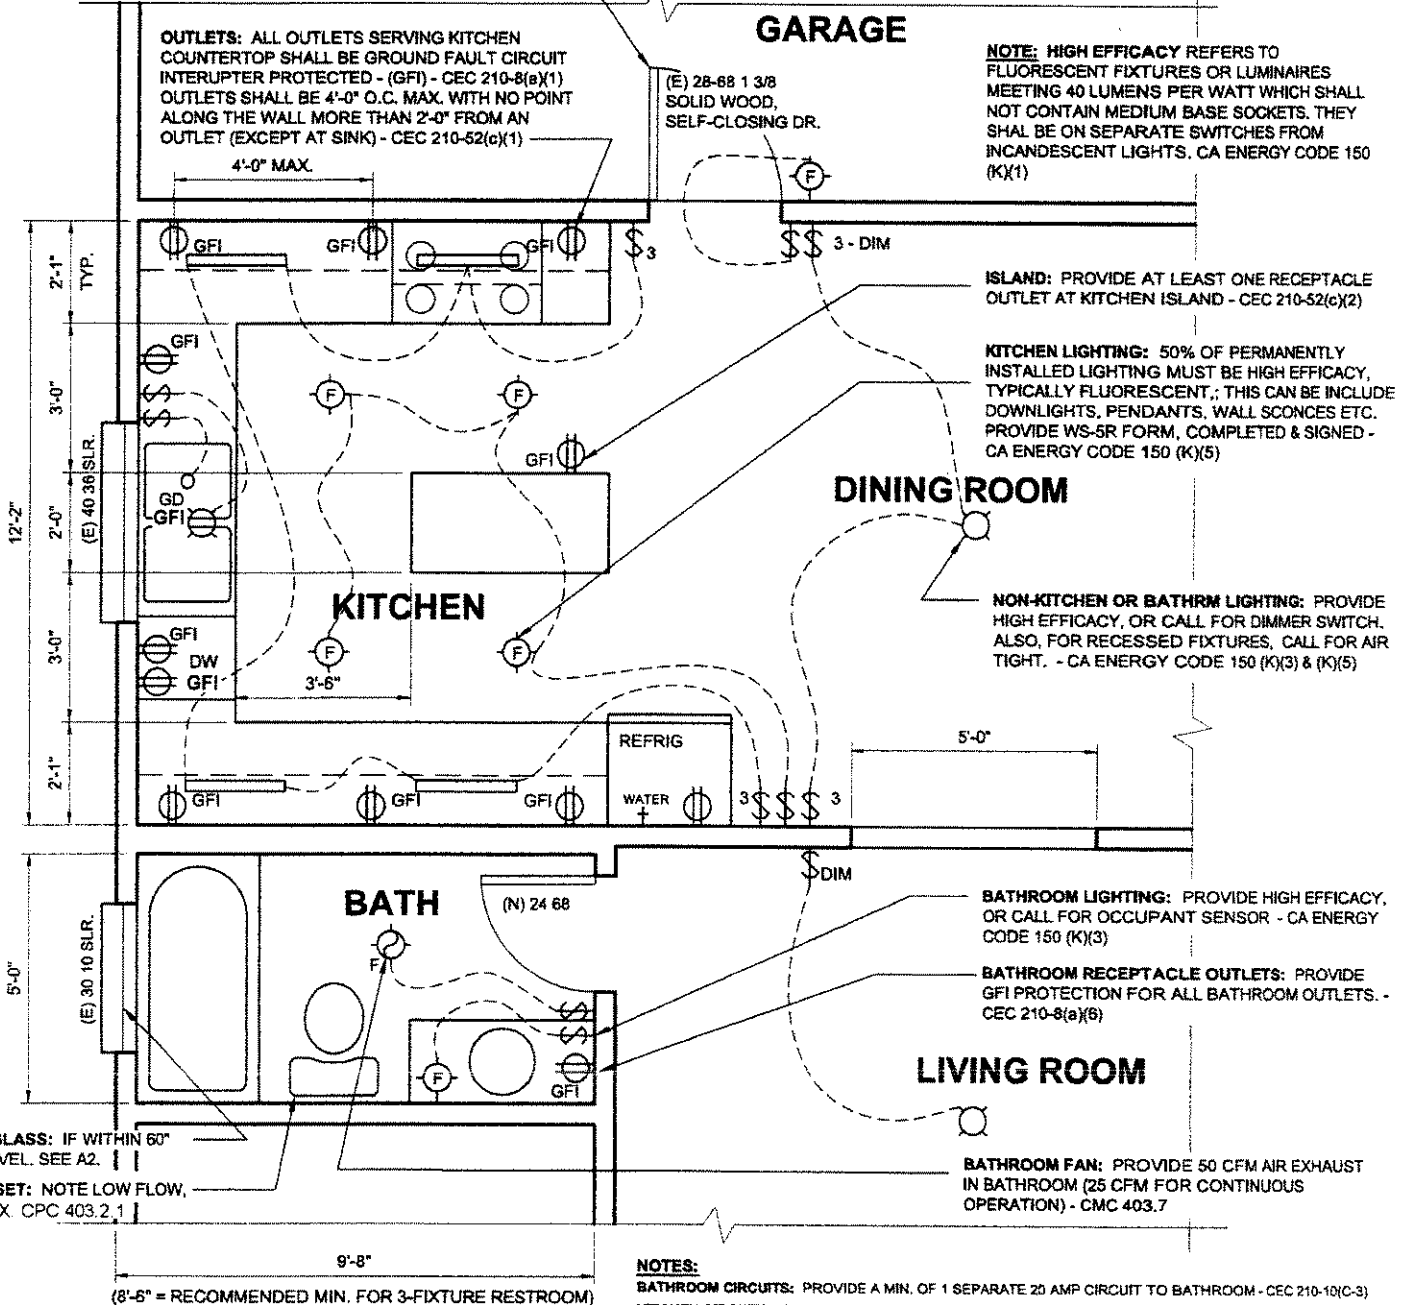

FLOOR PLAN

LEGEND: FOR LARGER PROJECTS, PROVIDE COMPLETE LEGEND FOR ALL SYMBOLS.

NOTE: All new receptacles must be 'Tamper-Resistant' per CEC 406.11

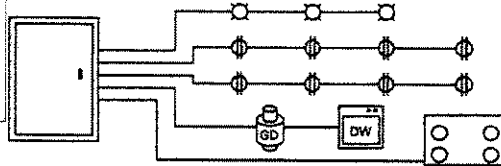

Provide Title Block. Leave margin on all sides.

This scale is for example only. Use 1/8" or 1/4" = 1'-0". Typical min. sheet size is 11" x 17" (8 1/2" X 11" for small projects.)

NAME, ADDRESS AND PHONE NO. OF DESIGNER
 XXX XXX XXX XXX
 XXX XXX XXX XXX

EXAMPLE RESIDENCE

PLAN

SCALE: 1/4" = 1'-0"

WET SIGNATURE OF DESIGNER ON EACH SHEET (AND PROFESSIONAL STAMP IF APPLICABLE)

SAMPLE DRAWING

DATE:

SHEET NO.

A10